

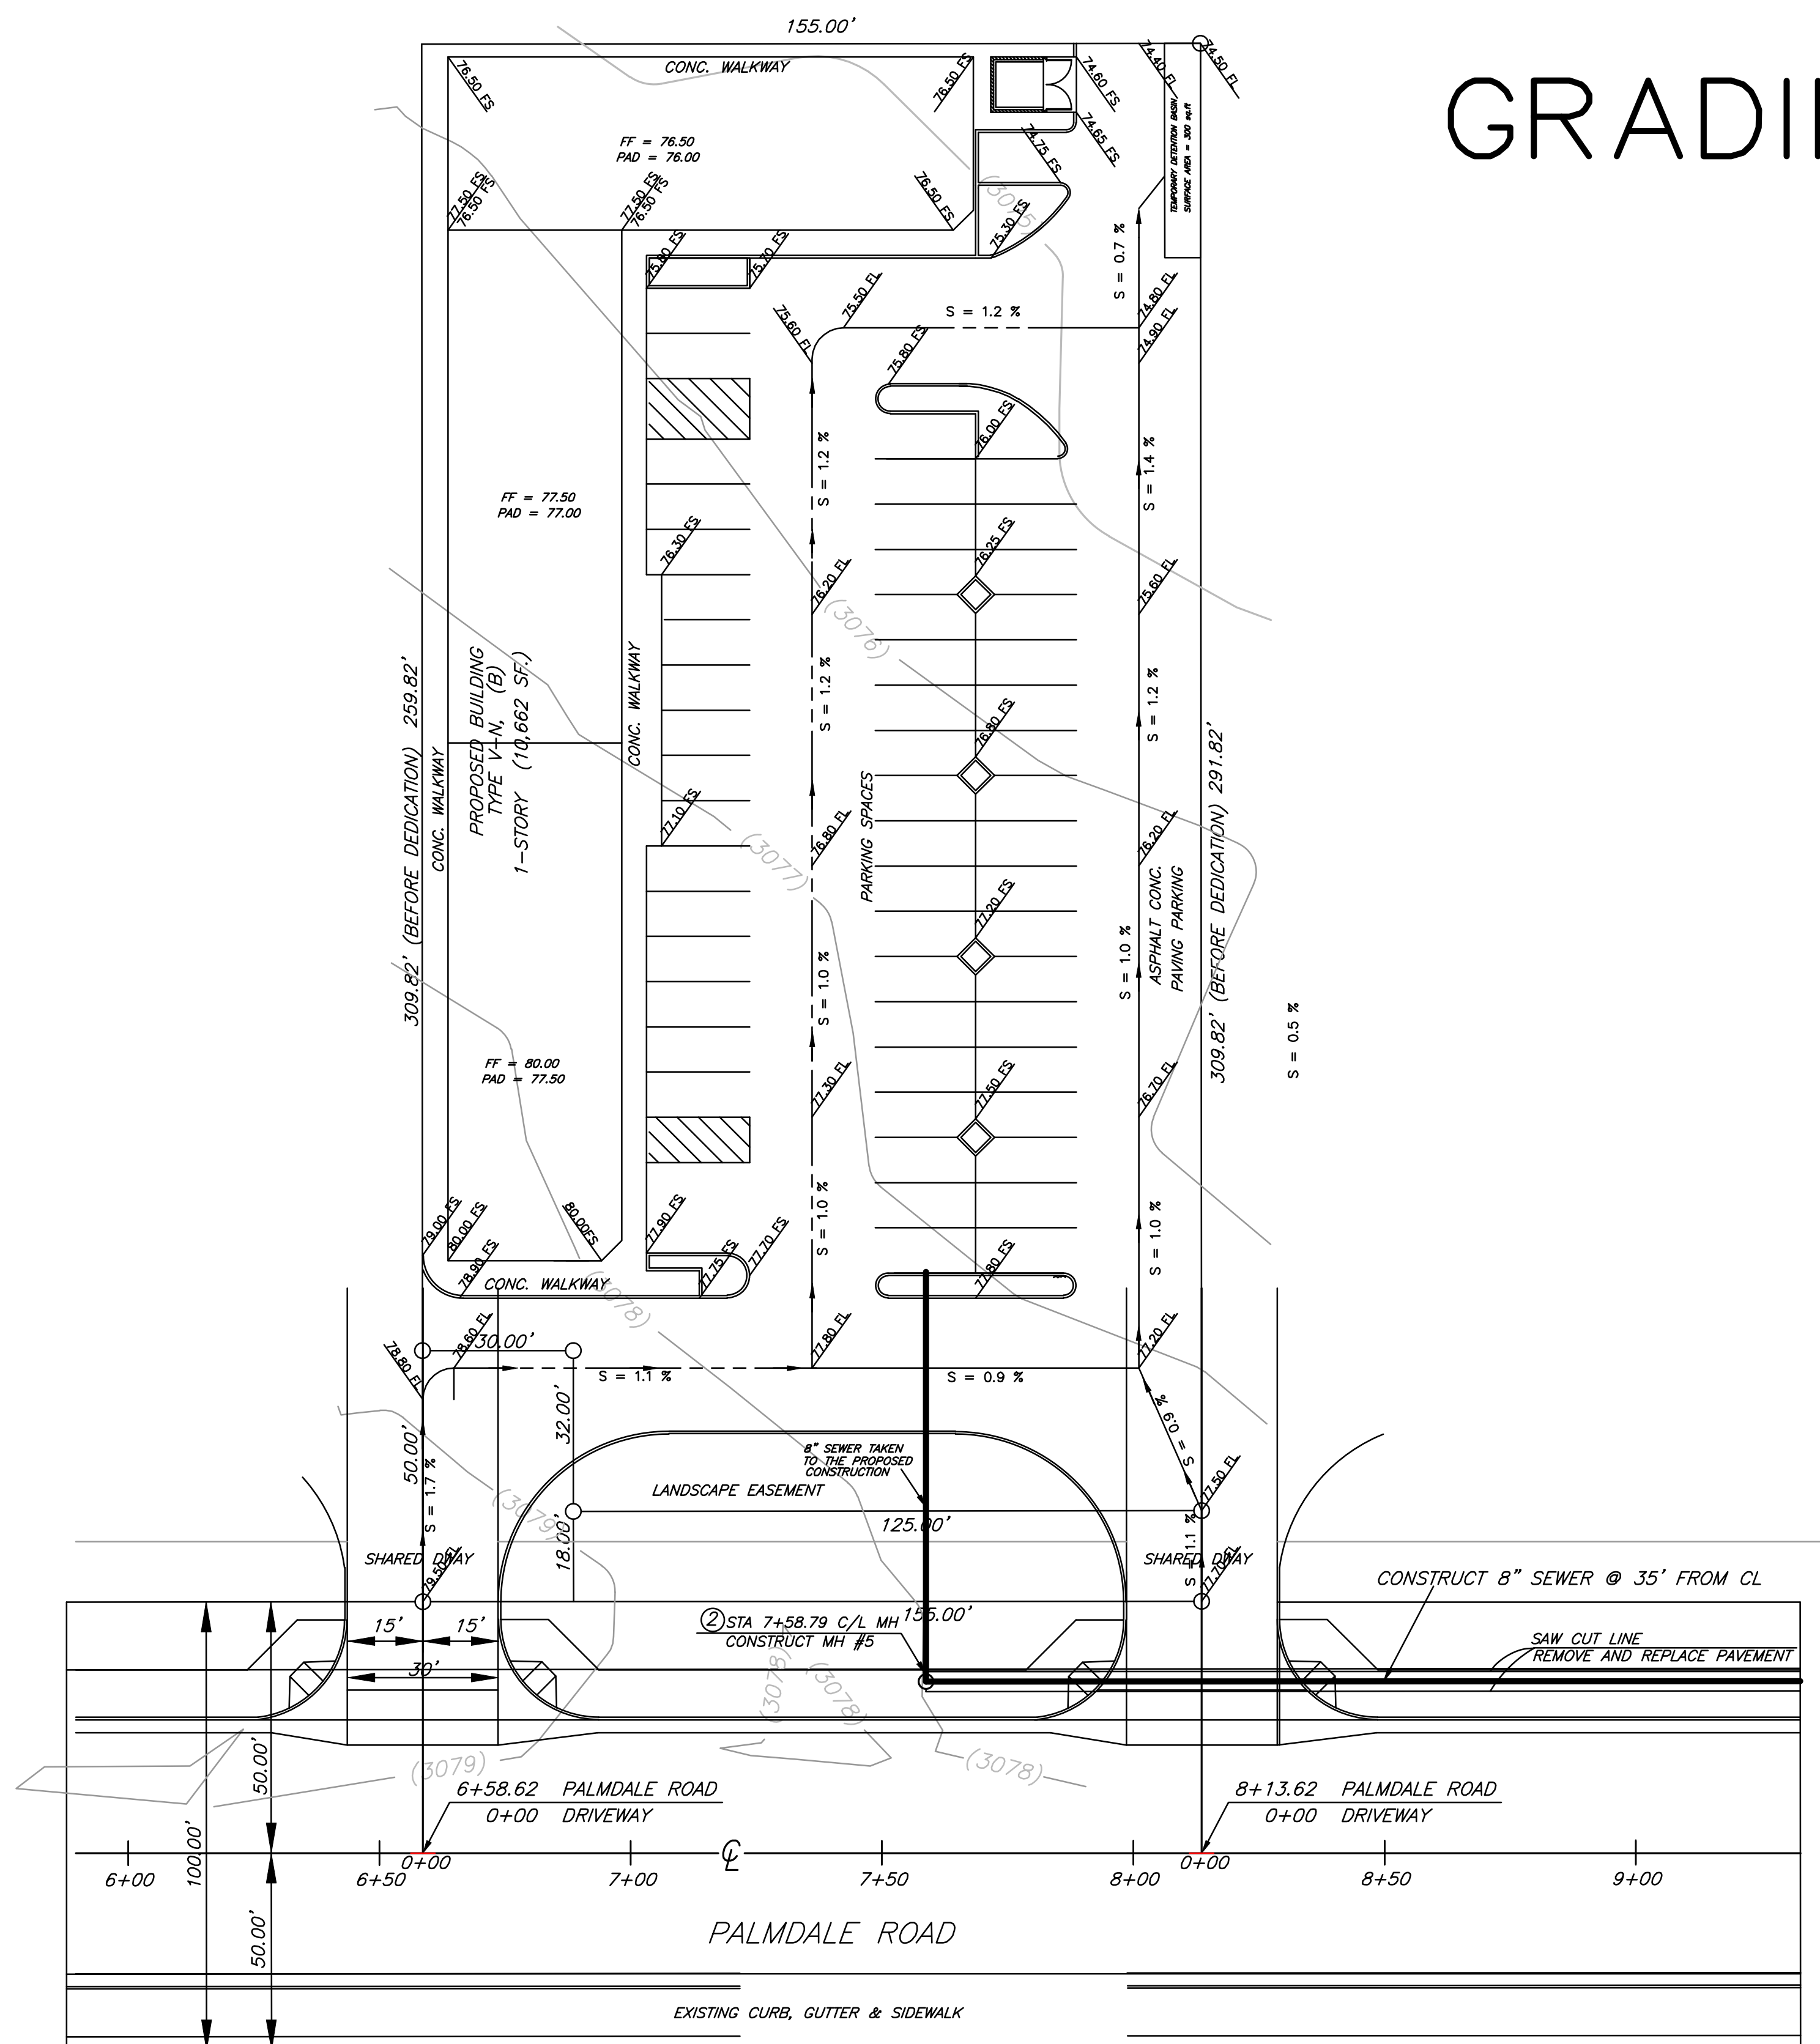
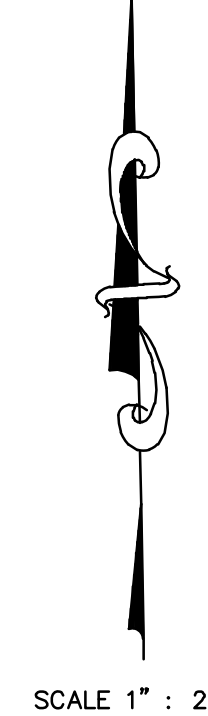


# GRADING PLAN

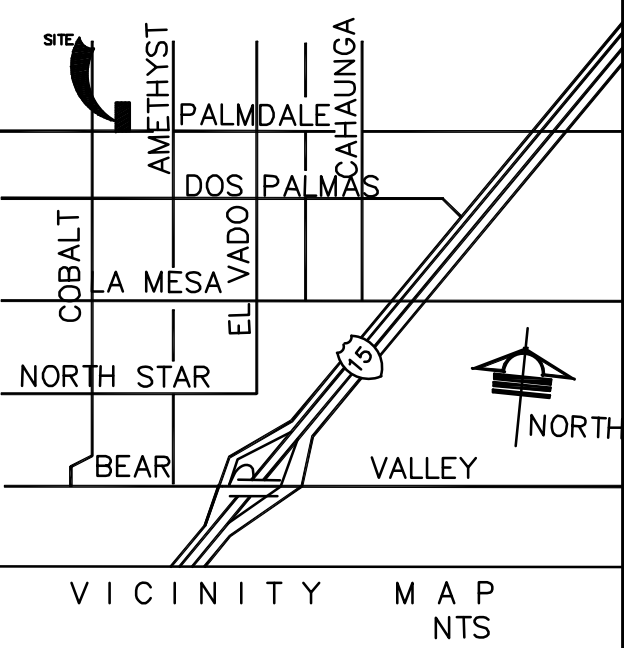

**ABBREVIATIONS:**

- AB = AGGREGATE BASE
- AC = ASPHALT PAVEMENT
- BW = BACK OF WALK
- CB = CATCH BASIN
- CF = CURB FACE
- CLF = CHAIN LINK FENCE
- EG = EDGE OF GUTTER
- EM = ELECTRIC METER
- EMH = ELECTRIC MANHOLE
- EP = EDGE OF PAVEMENT
- EPB = ELECTRIC PULL BOX
- EV = ELECTRIC VAULT
- FF = FINISH FLOOR
- FG = FINISH GRADE
- FH = FIRE HYDRANT
- FL = FLOW LINE
- FS = FINISH SURFACE
- GB = GRADE BREAK
- GM = GAS METER
- HP = HIGH POINT
- INV = INVERT ELEVATION
- LP = LOW POINT
- LT = PARKING LOT LIGHT
- MP = METAL POST
- NG = NATURAL GROUND ELEVATION
- PA = PLANTER
- PM = PARKING METER POST
- PP = POWER POLE
- PB = PULL BOX
- PCC = PORTLAND CEMENT CONCRETE
- RCE = REGISTERED CIVIL ENGINEER
- RW = RETAINING WALL
- SB = SPLASH BOX
- SDMH = STORM DRAIN MANHOLE
- SMH = SEWER MANHOLE
- SPB = SIGNAL PULL BOX
- ST. LT. = STREET LIGHT
- TC = TOP OF CURB
- TC = TOP OF GRATE ELEVATION
- TEL.M.H. = TELEPHONE MANHOLE
- TF = TOP OF FOOTING
- TRW = TOP OF RET. WALL
- VB = ELECTRICAL VENTILATION BOX
- WM = WATER METER
- WV = WATER VALVE
- (000.0) = EXISTING ELEVATION
- 000.0 = PROPOSED ELEVATION
- E - - - - = ELECTRICAL
- G - - - - = GAS
- W - - - - = WATER
- S - - - - = SEWER
- T - - - - = TELEPHONE

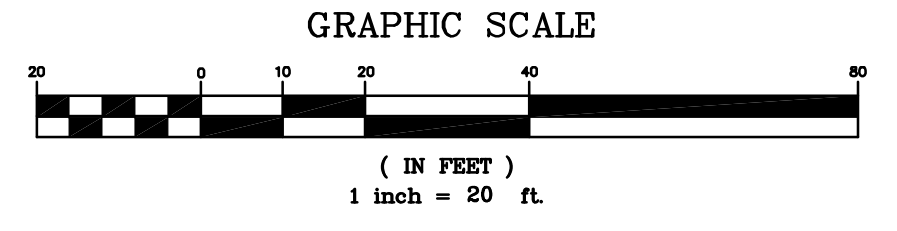

BENCH MARK

**IMPORTANT NOTICE**

CALL UNDERGROUND SERVICE ALERT  
TOLL FREE 1-800-277-2600  
TWO WORKING DAYS BEFORE YOU DIG

MARK	REVISIONS	APPR. DATE

BUILDING DEPARTMENT

GRADING PLAN  
AMETHYST ROAD  
HORIZONTAL SCALE 1" = 20' SHEET 2 OF 3

DESIGN BY: \_ASG\_ DRAWN BY: \_ASG\_ CHECK BY: \_